




ROOF PLAN
LOWER DUCTWORK
1:100

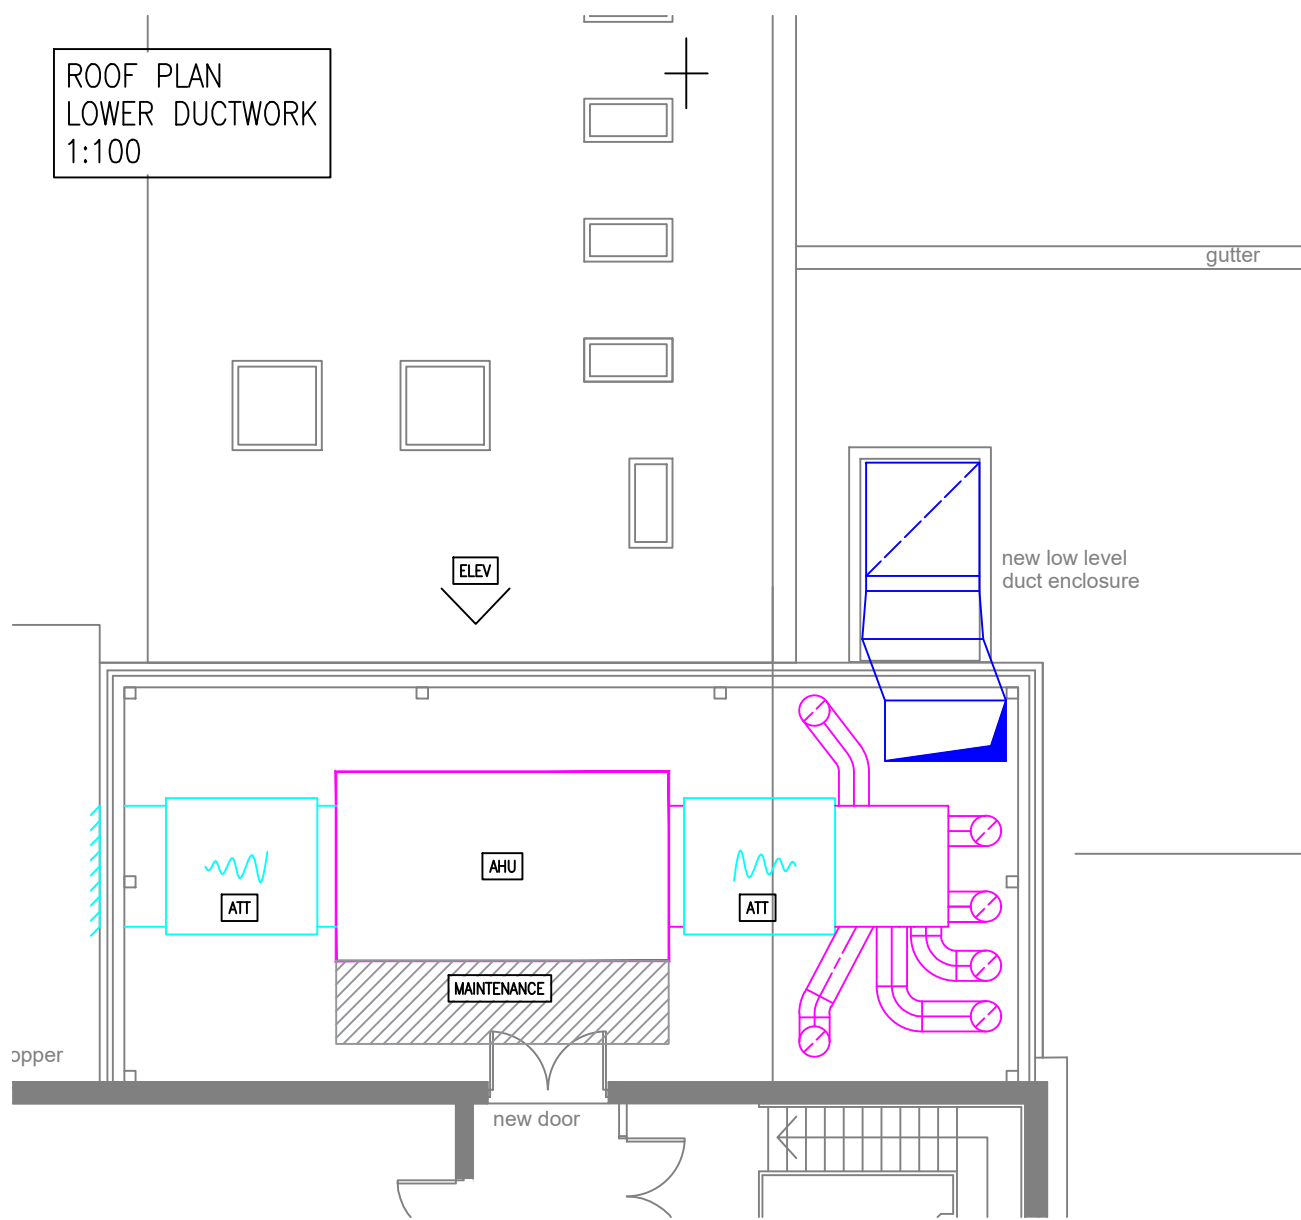

ROOF PLAN
UPPER DUCTWORK
1:100

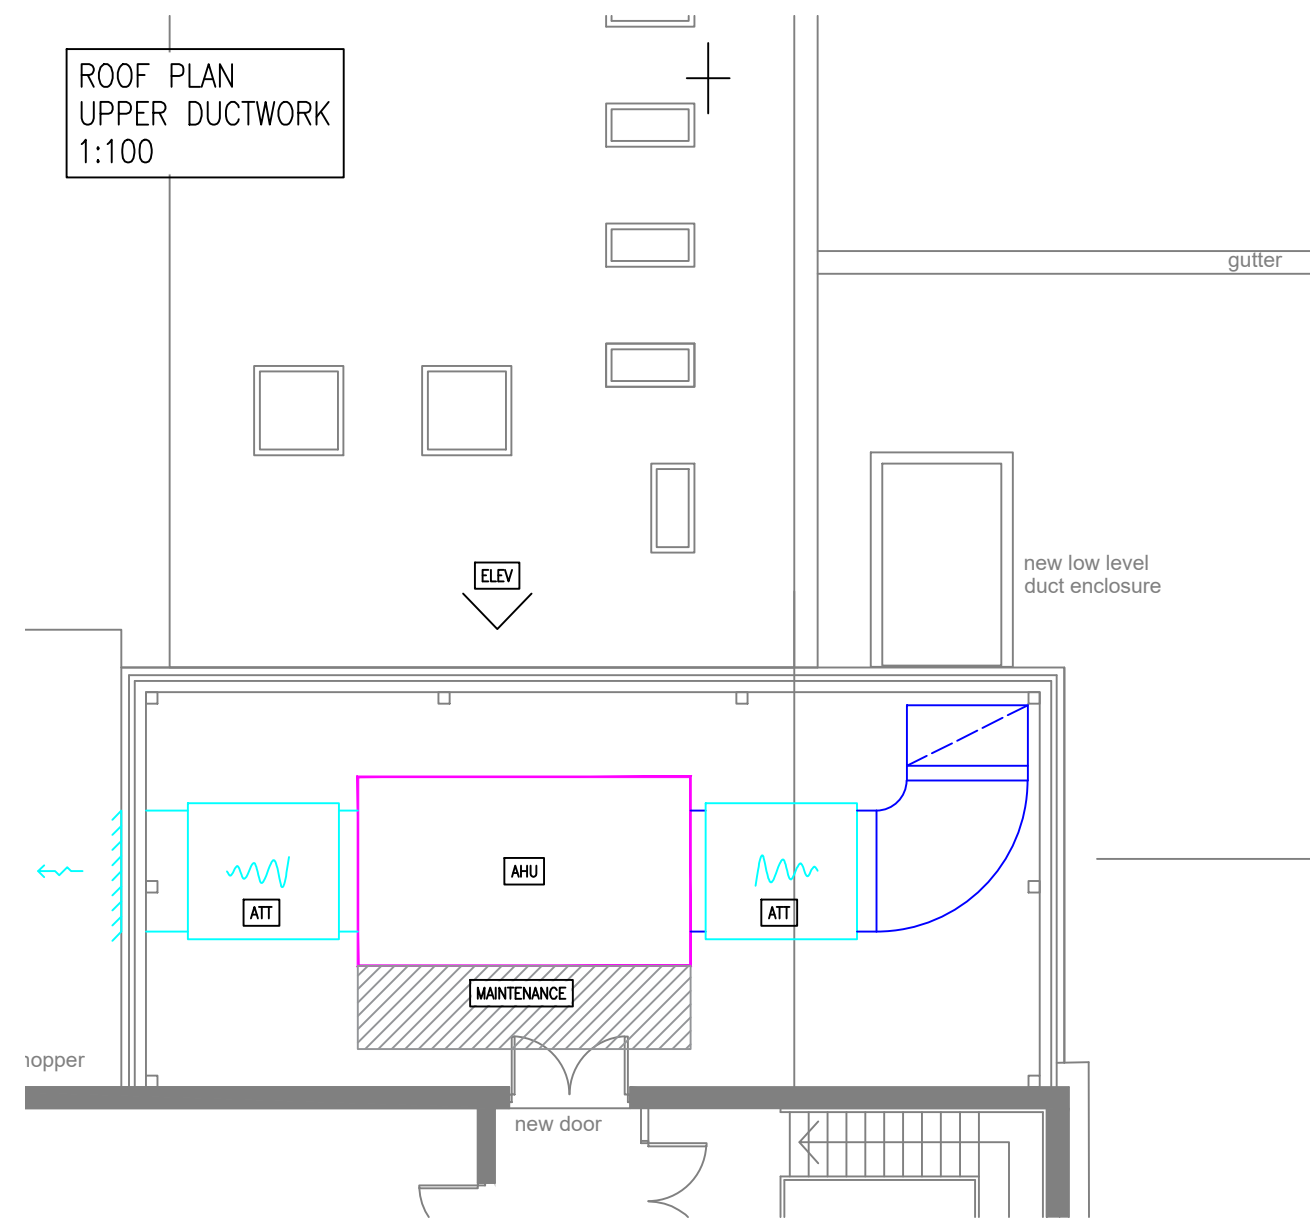

PLANT ELEV 1:50

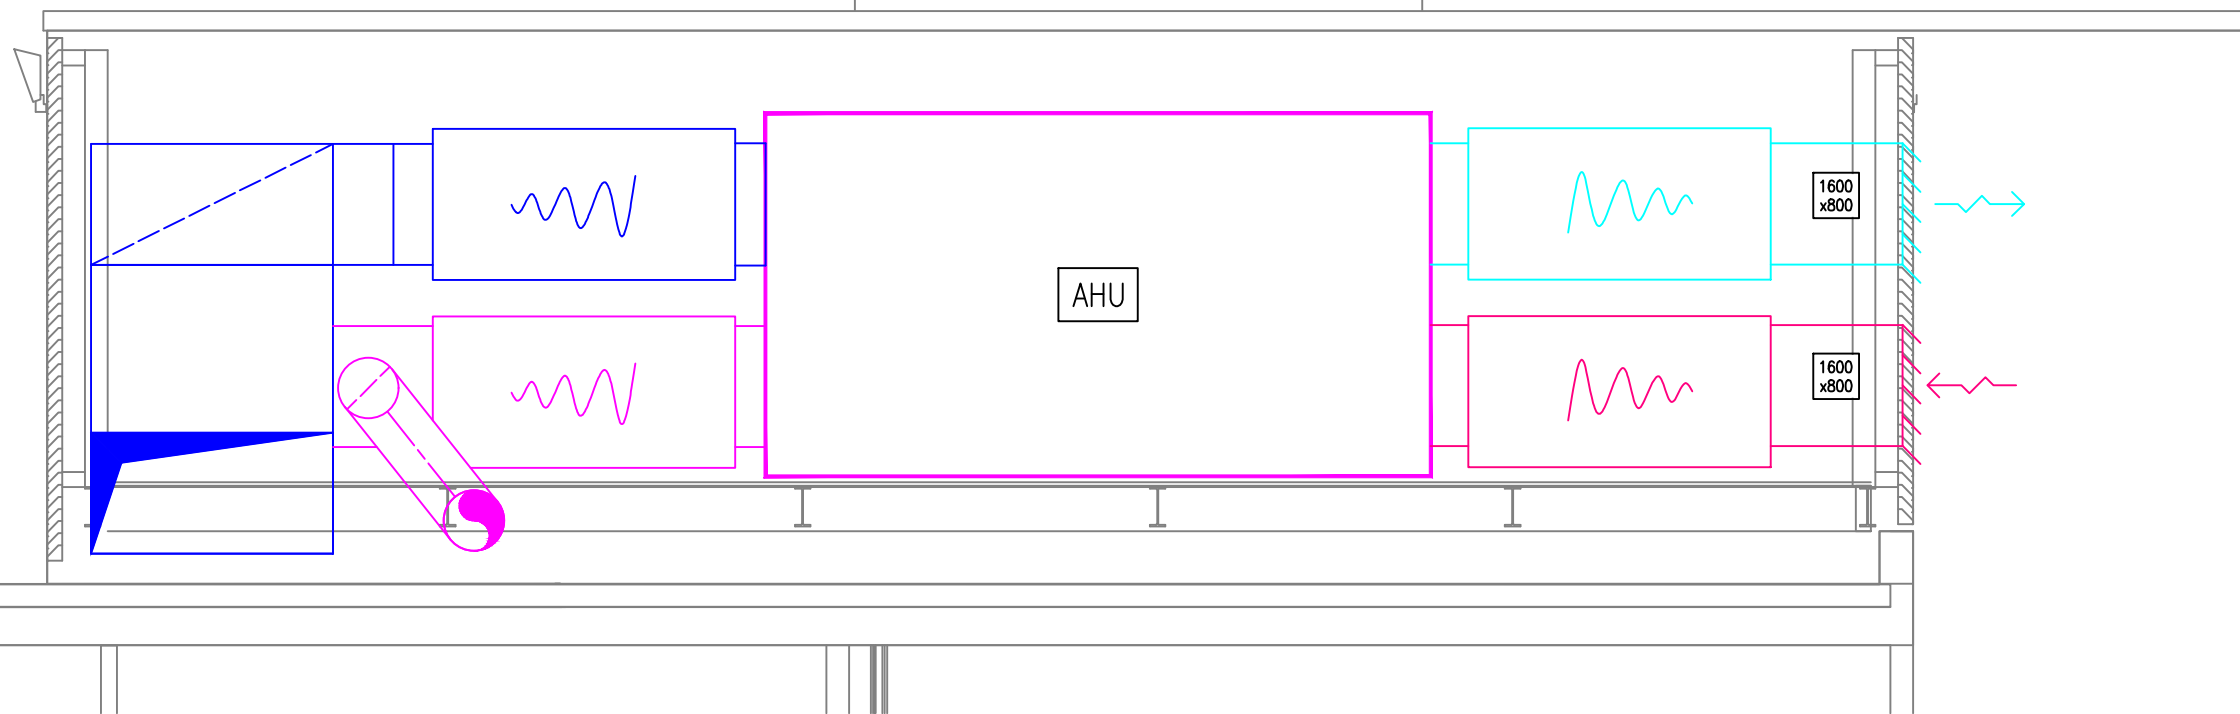

Do Not Scale
This drawing is the copyright of Henderson Green Partnership Guernsey.
This is not a working drawing.
Figured dimensions are to be checked on site.
This drawing shall be read in conjunction with all relevant consultants and/or specialist drawings/documents.
Any discrepancies or variations shall be notified to the engineer prior to commencement of works.

Issue Date JUL'21 CAD JHPG ENG JHPG
DESCRIPTION

P1 PRELIMINARY ISSUE

hendersongreen 
Consulting Engineers

Jersey Guernsey
t: 01534 871890 t: 01481 729967

Client
THE LADIES COLLEGE

Project
LADIES COLLEGE HALL

Title
**AHU SKETCH SCHEME - ROOF
OPTION D**

Originators CAD/ENG. Original Date Scale @ A3
JHPG JUL'21 STATED

Job No. Drawing No. Issue
P21015 SK11.8.21 R P1